


Load In Door
(level with street)


Downstairs - Dressing Room Corridor to Stage
Upstairs - Dressing Room Corridor to Balcony

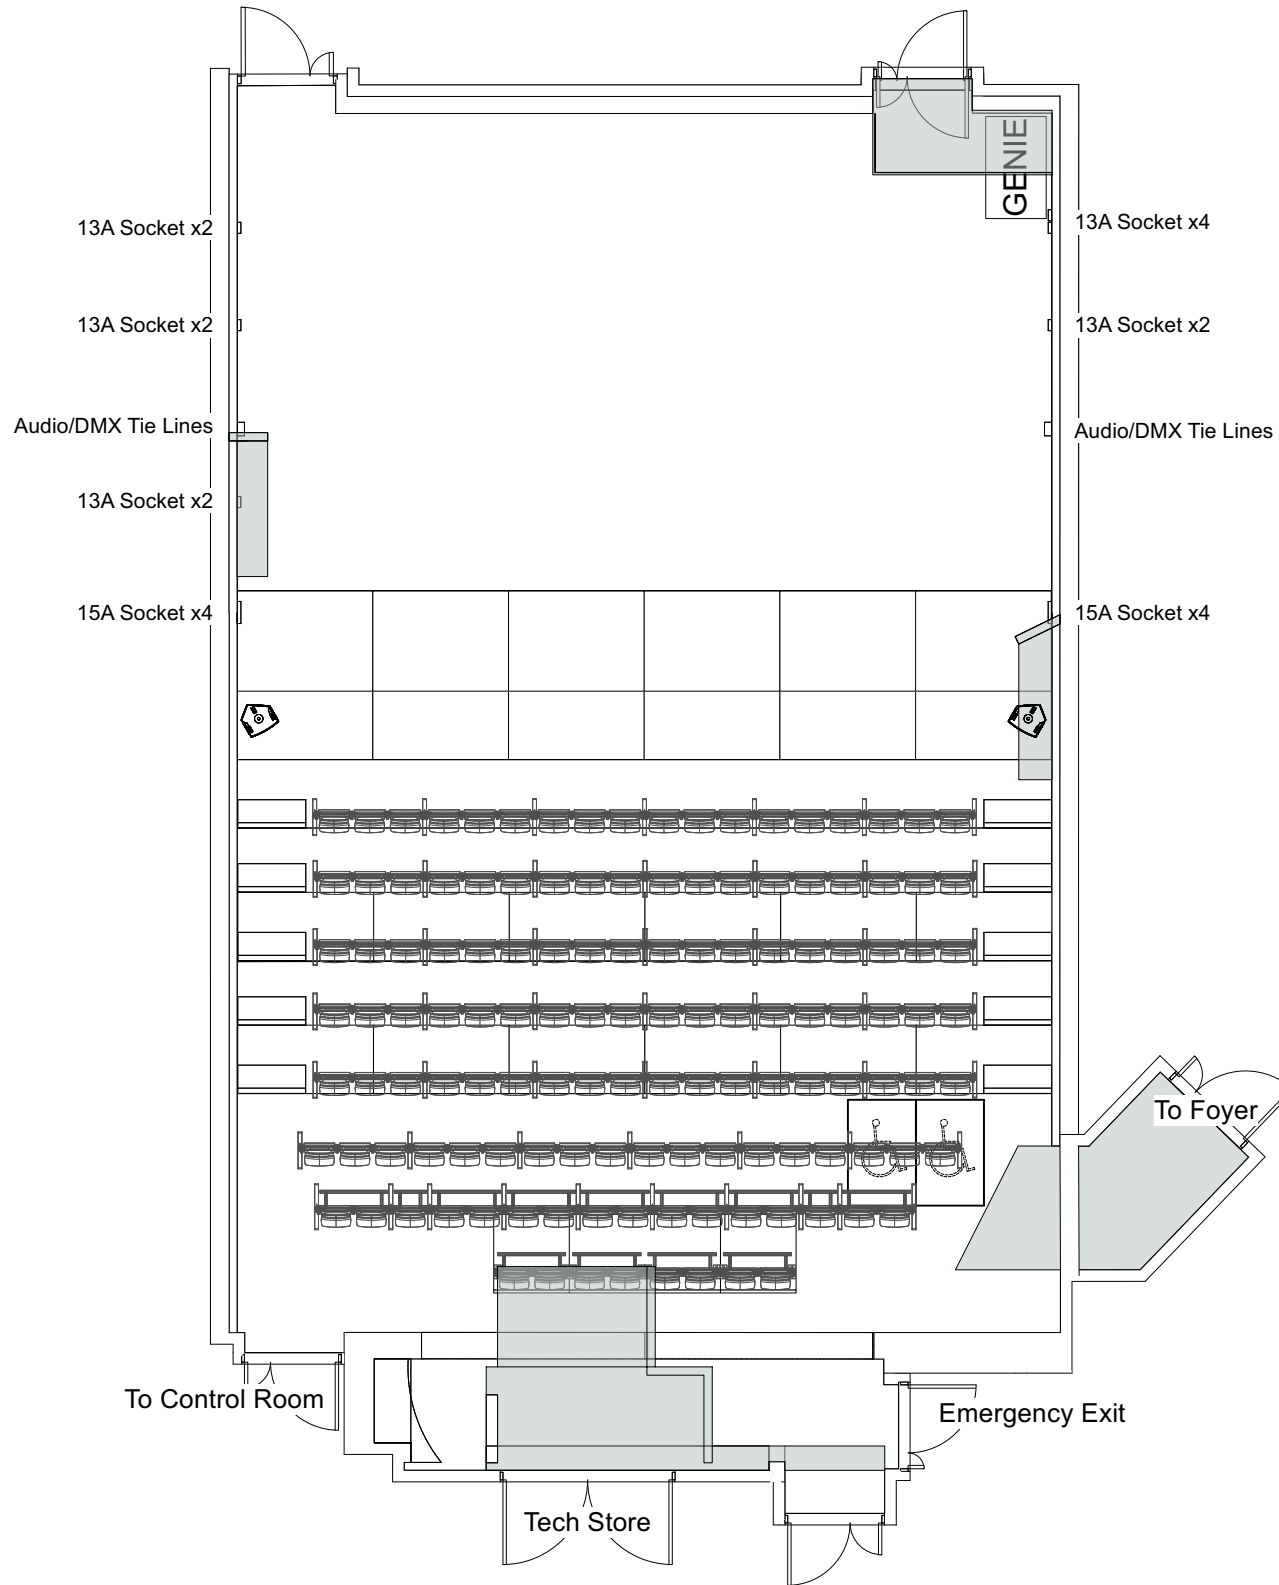

Jacksons Lane		
Sheet Title : Ground Plan Extension 1:100		
	Scale :1:100	Date : 01/07/2022
	Drawn By :S Jackson	

Load In Door
(level with street)


Downstairs - Dressing Room Corridor to Stage
Upstairs - Dressing Room Corridor to Balcony

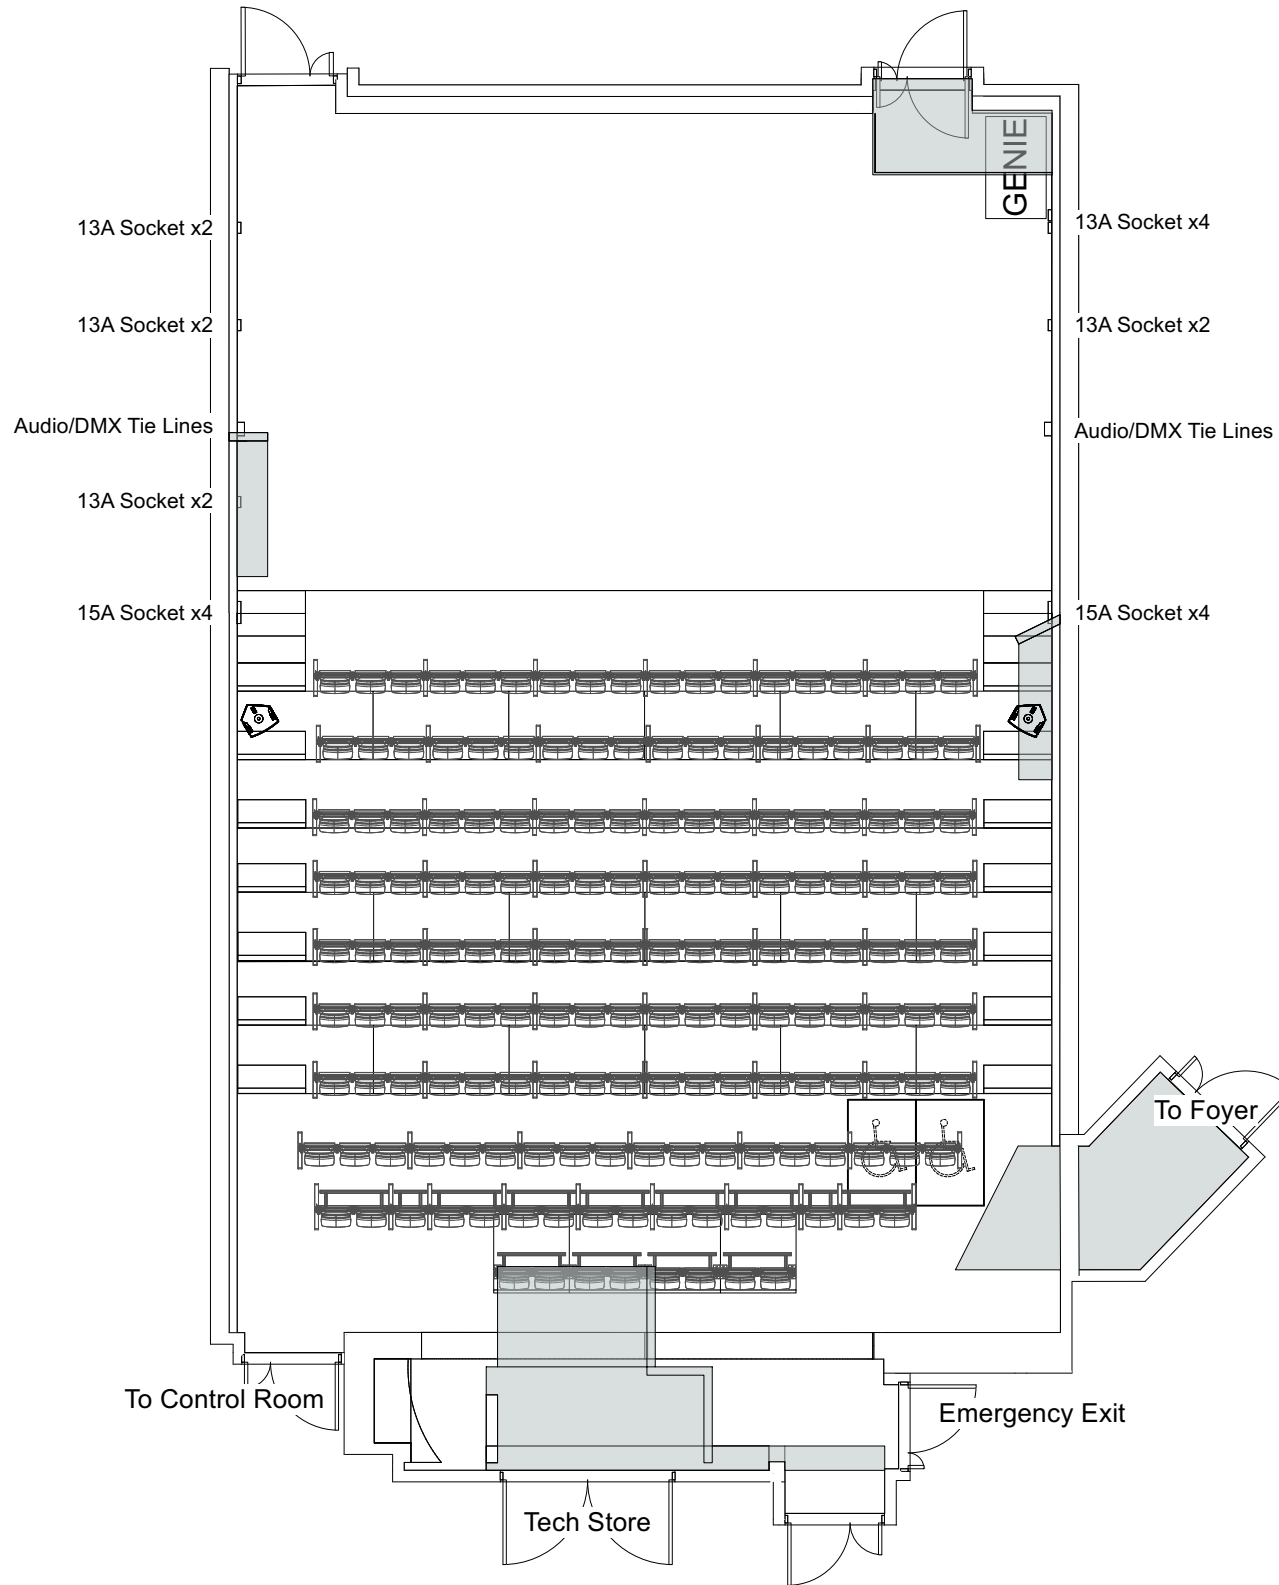

Jacksons Lane		
Sheet Title: Ground Plan 1:100 No Extension		
	Scale: 1:100	Date: 01/07/2022
	Drawn By: S Jackson	

Load In Door
(level with street)

Downstairs - Dressing Room Corridor to Stage
Upstairs - Dressing Room Corridor to Balcony

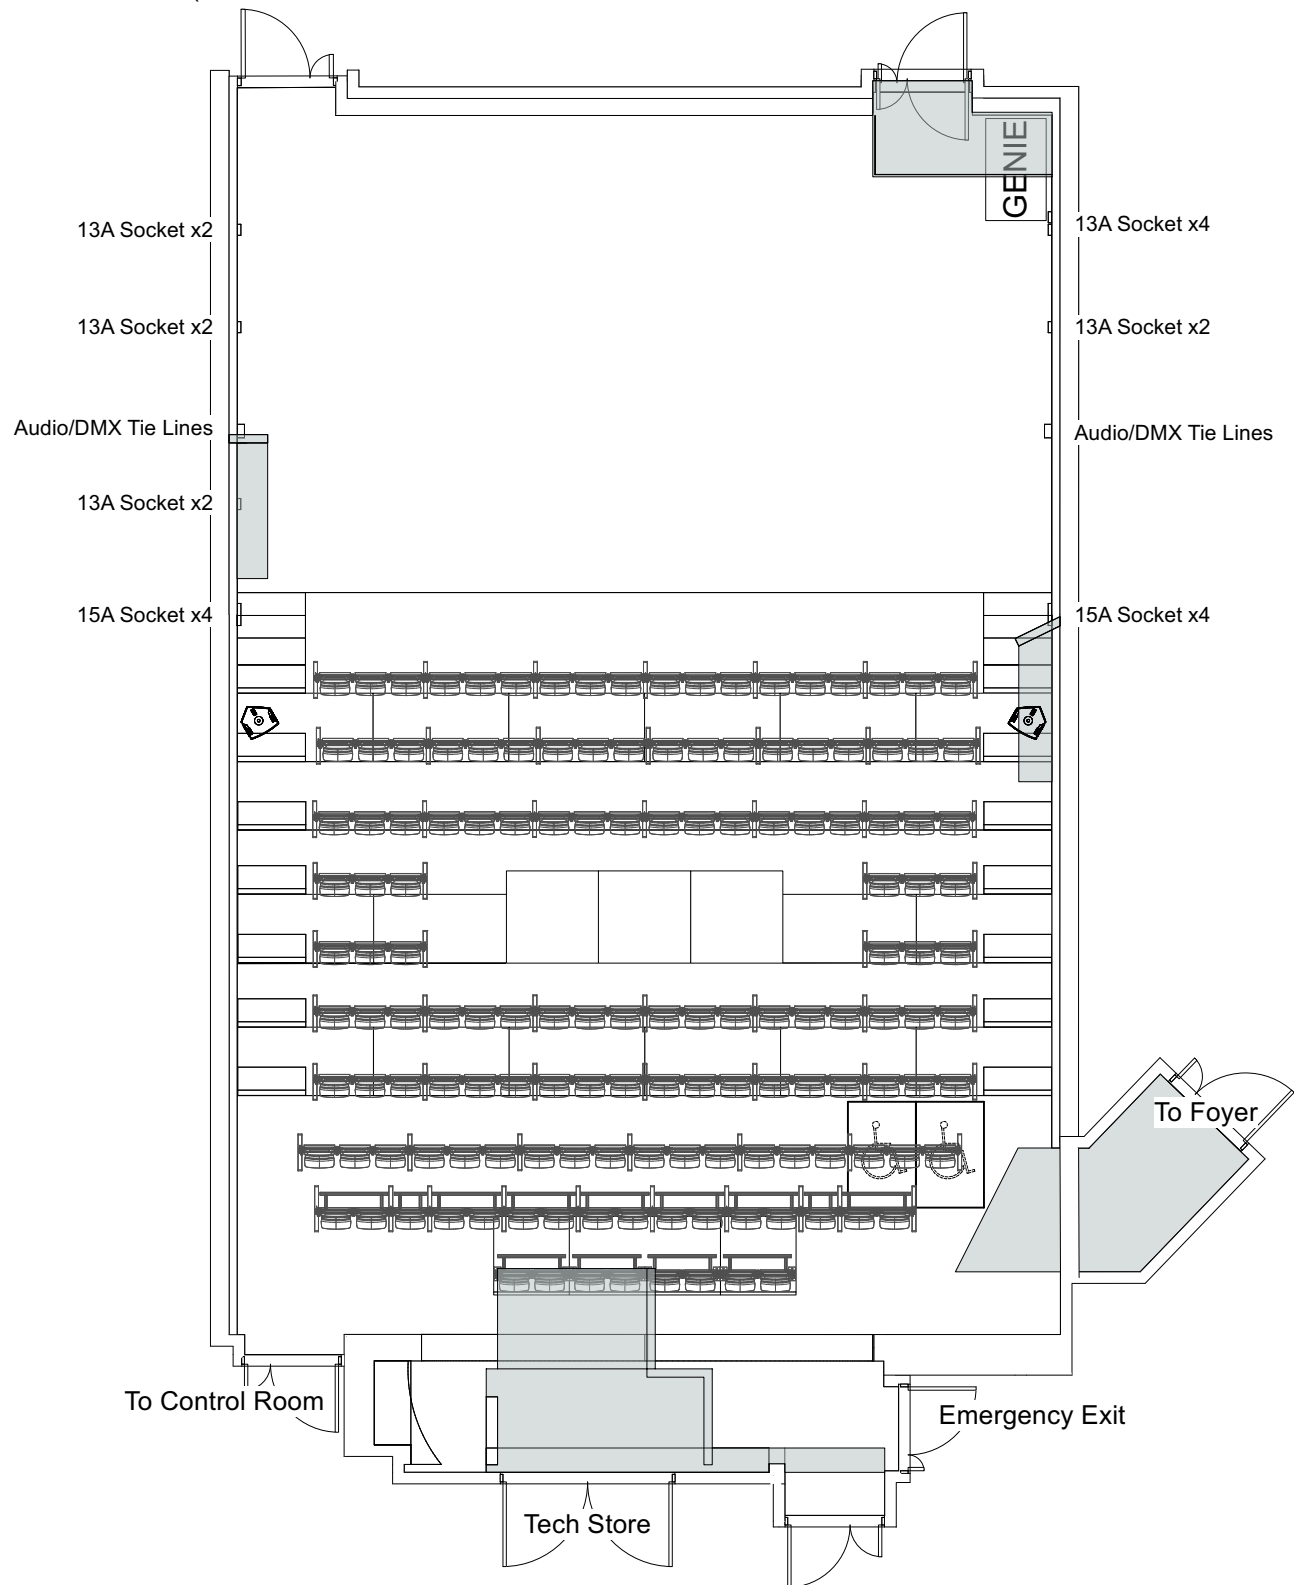

Jacksons Lane		
Sheet Title : Ground Plan 1:100 Production Desk		
	Scale :1:100	Date : 01/07/2022
	Drawn By :S Jackson	

Load In Door
(level with street)

Downstairs - Dressing Room Corridor to Stage
Upstairs - Dressing Room Corridor to Balcony

LX3 - 72 → 61

LX2 - 60 → 49

LX1 - 48 → 37

ADV - 36 → 25

FoH 1 - 24 → 13

FoH 2 - 12 → 1

FLOOR
SR
93-96

FLOOR
SL
89-92

SR - 81 → 88

SL - 73 → 80

GENIE

LX3.5

LX3

LX2.5

LX2

LX1.5

LX1

LX0.5

ADV

FoH 1

FoH 2

To Control Room

Emergency Exit


Tech Store

To Foyer

Jacksons Lane		
Drawing Title		
Lighting Plan Circuits 1-100		
Drawing Number	Drawn By	Date
Drawing No.	Drawn By	Date: 01/07/2022
CAD File Name	Drawn By: S. Jackson	
File Name		

Load In Door
(level with street)


Downstairs - Dressing Room Corridor to Stage
Upstairs - Dressing Room Corridor to Balcony

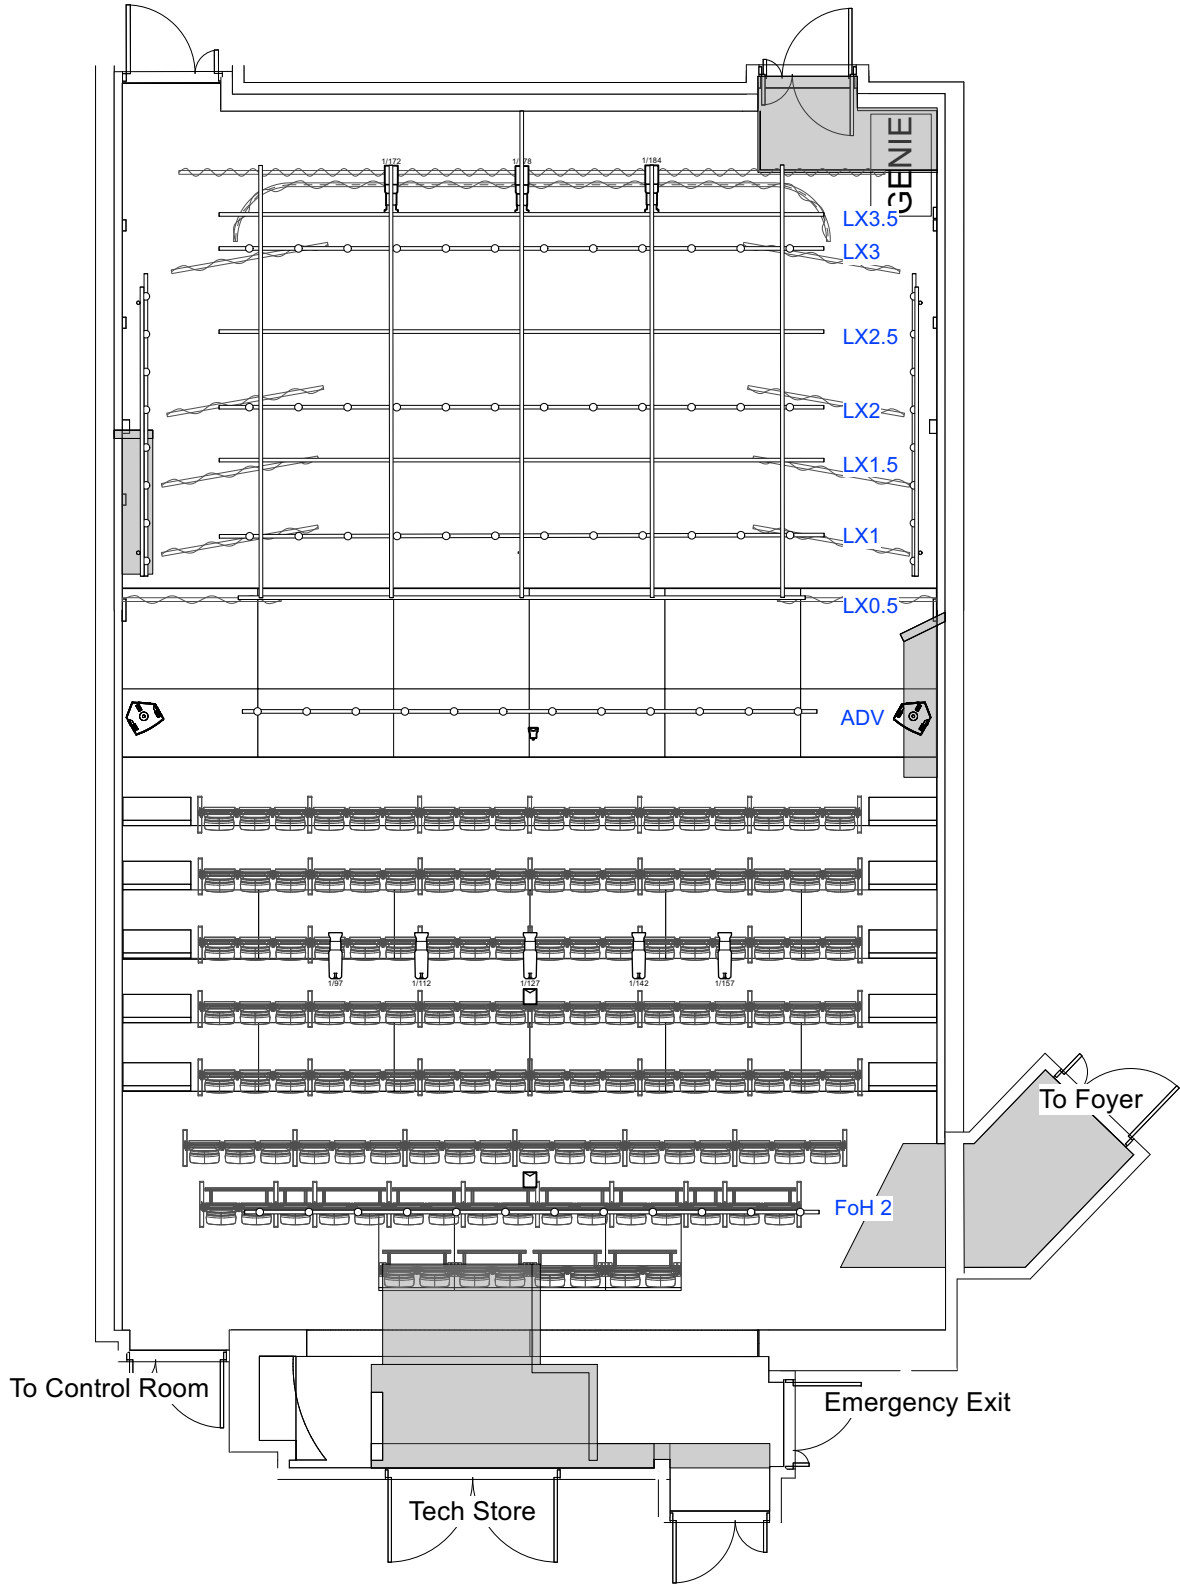

Jacksons Lane Drawing Title		
Lighting Plan 1:100 Extension		
Drawing Number	Drawn By	Date
Drawing No.	Scale: 1:100 Drawn By	Date: 01/07/2022
CAD File Name	Drawn By: S. Jackson	
File Name		

Load In Door
(level with street)


Downstairs - Dressing Room Corridor to Stage
Upstairs - Dressing Room Corridor to Balcony

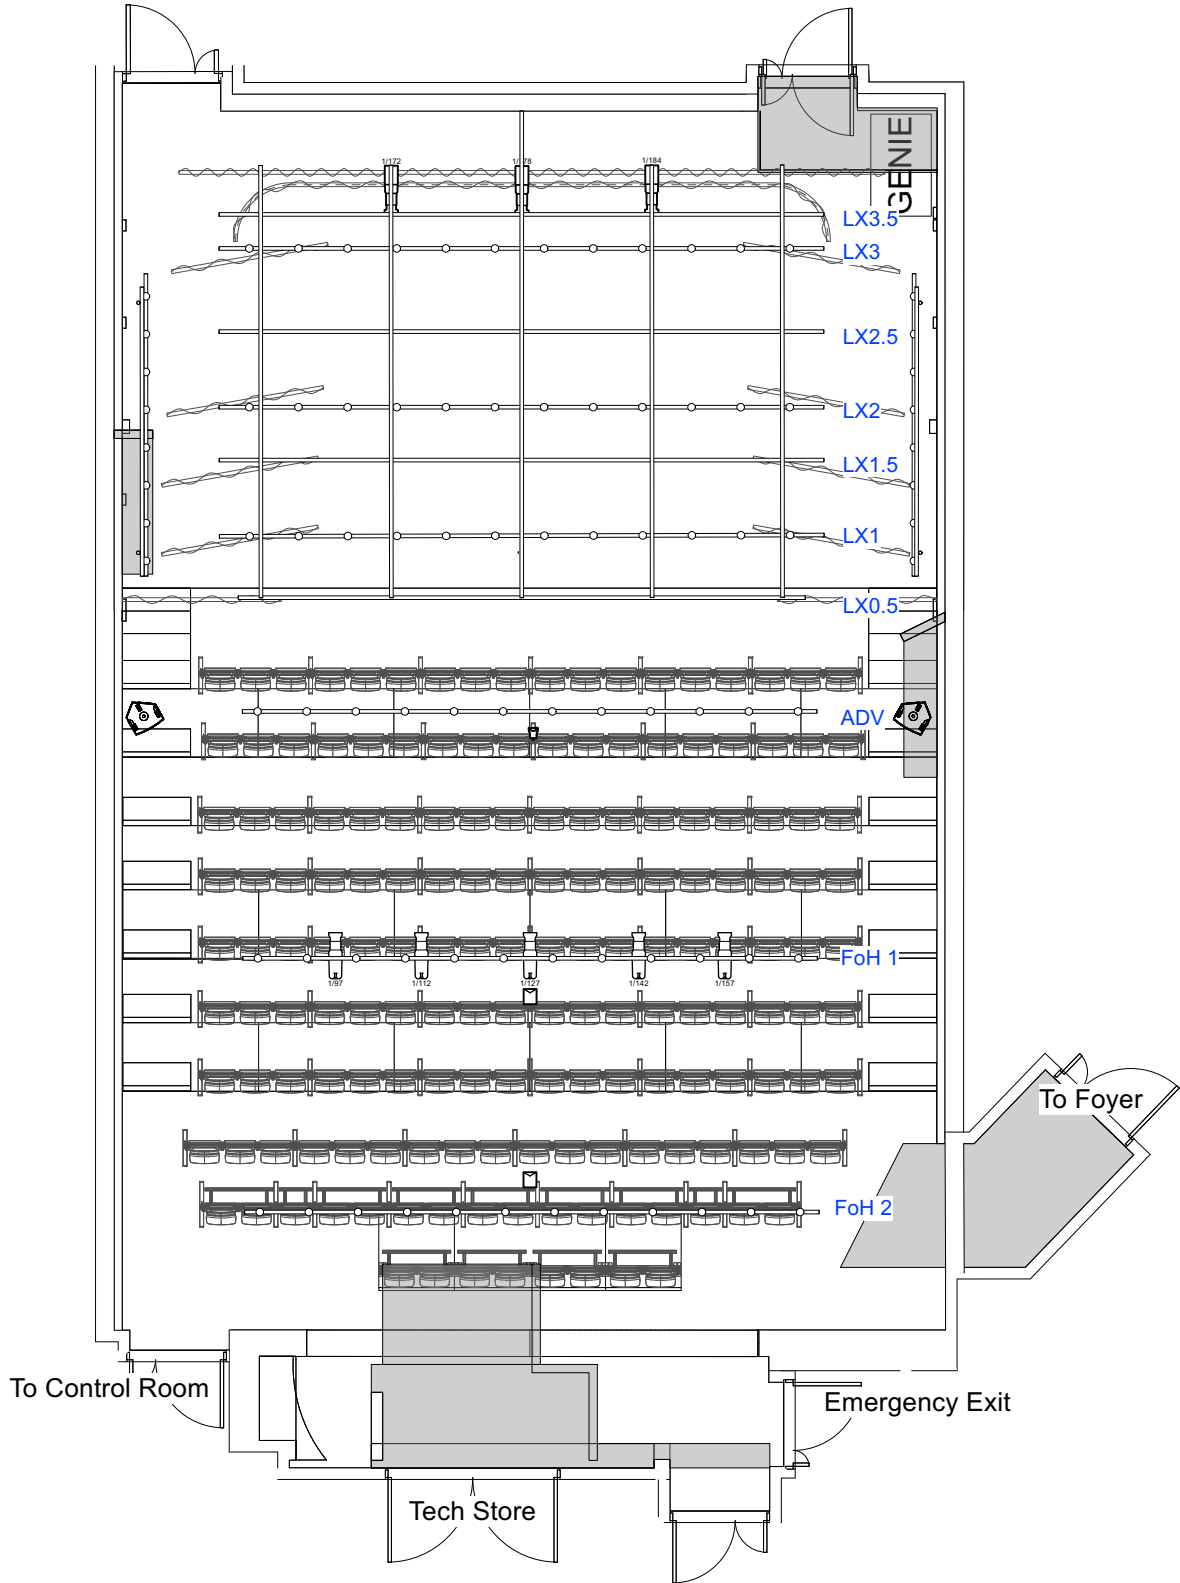

Jacksons Lane Drawing Title		
Lighting Plan 1:100-Full		
Drawing Number	Drawn By	Date
Drawing No.	Scale: 1:100 Drawn By	Date: 01/07/2022
CAD File Name	Drawn By: S. Jackson	
File Name		

Load In Door
(level with street)


Downstairs - Dressing Room Corridor to Stage
Upstairs - Dressing Room Corridor to Balcony

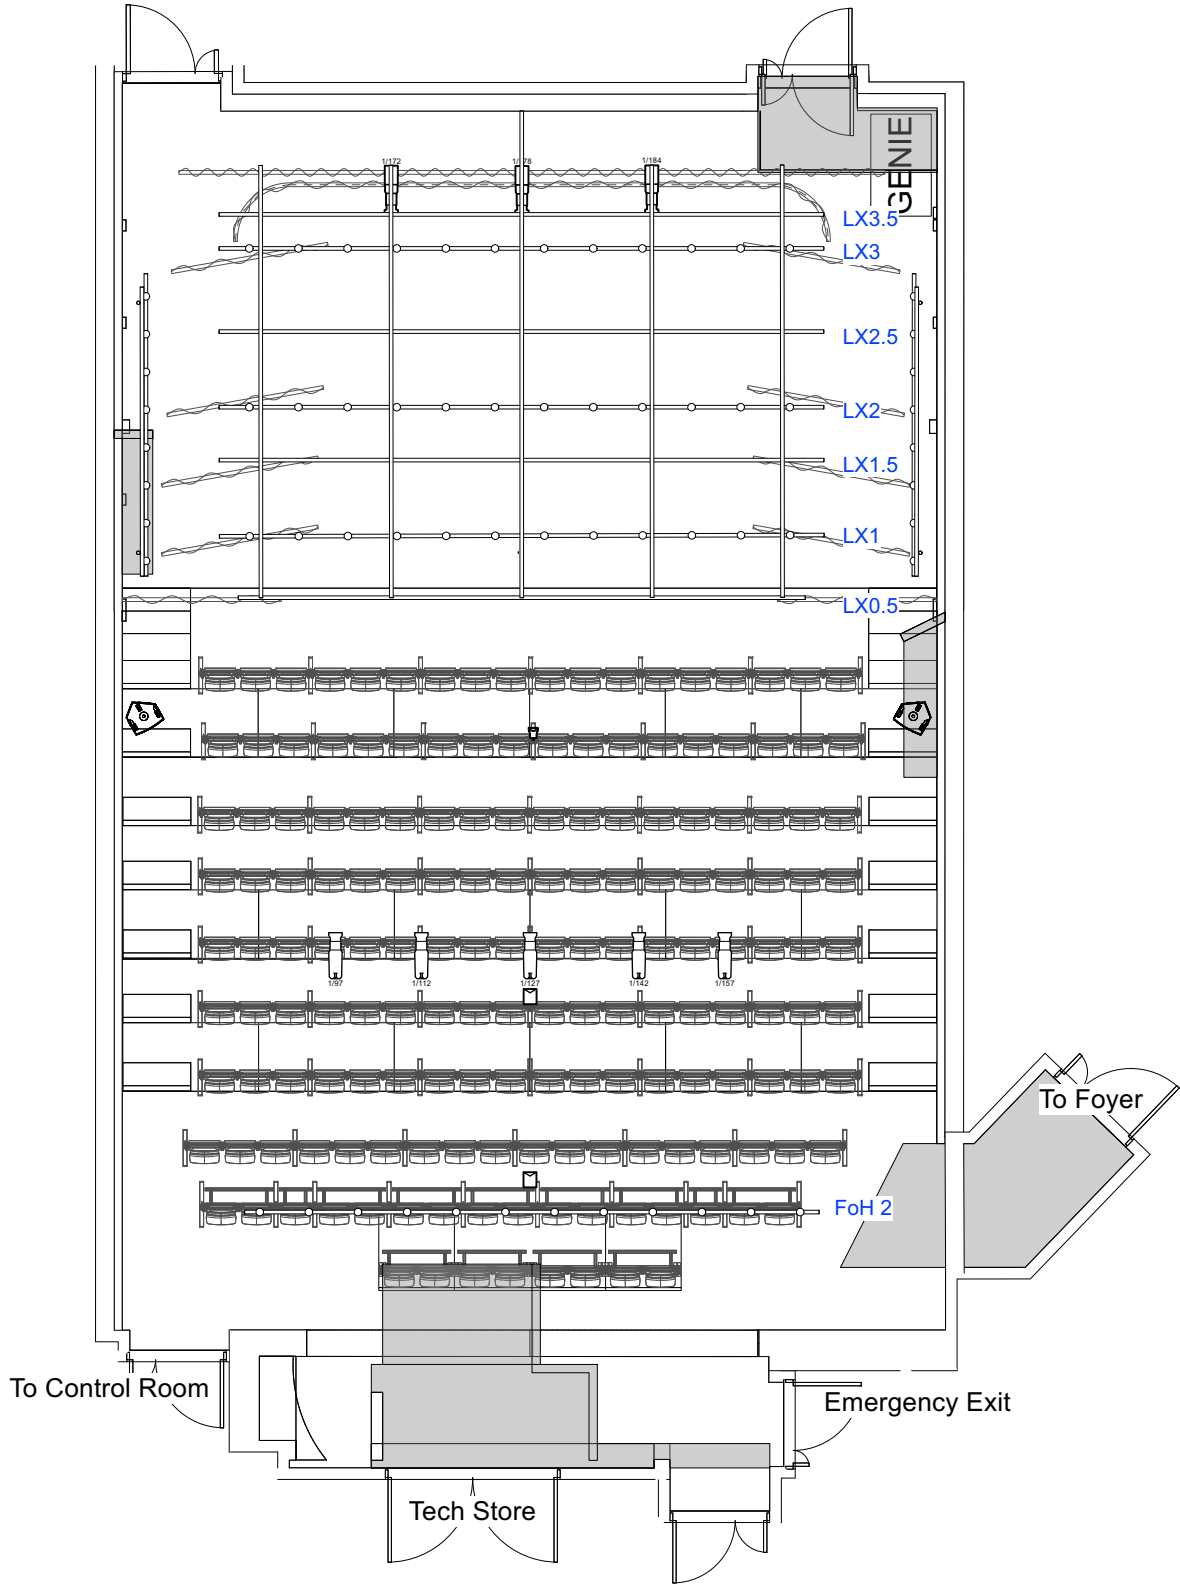

Jacksons Lane Drawing Title		
Lighting Plan 1:100 No Extension		
Drawing Number	Drawn By	Date
Drawing No.	Scale: 1:100 Drawn By	Date: 01/07/2022
CAD File Name	Drawn By: S. Jackson	
File Name		

Load In Door
(level with street)

Downstairs - Dressing Room Corridor to Stage
Upstairs - Dressing Room Corridor to Balcony

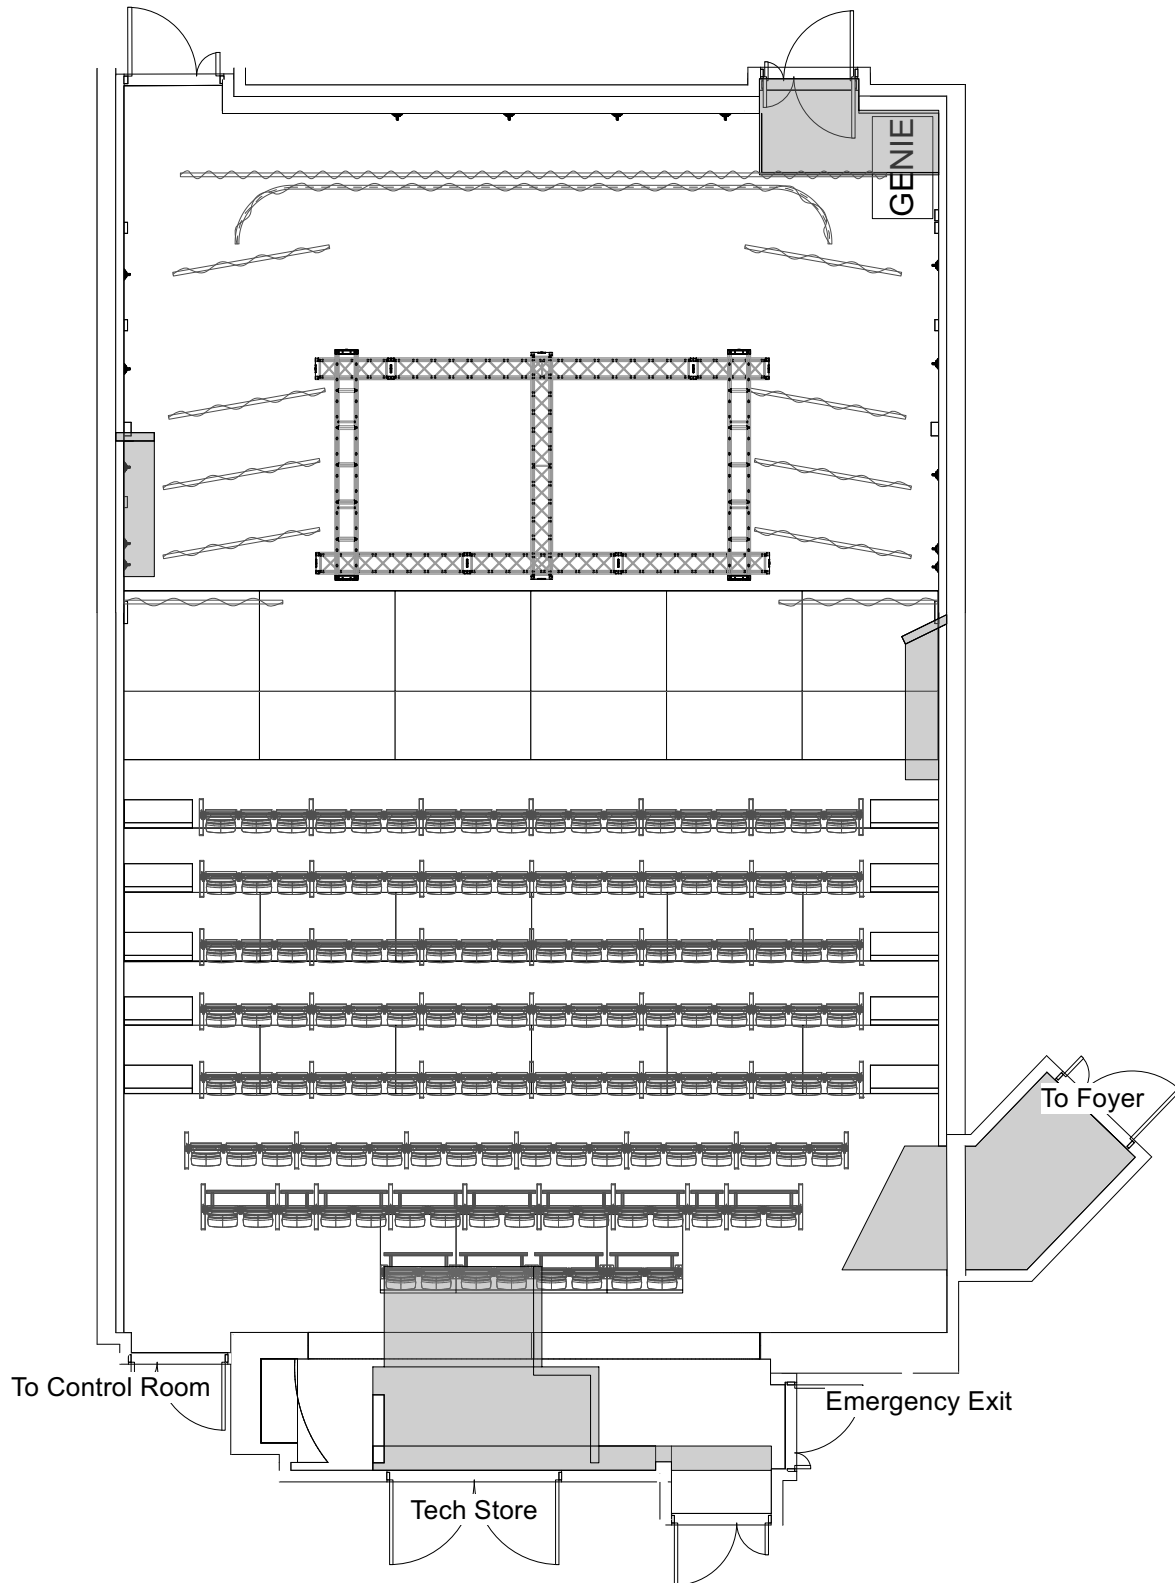

Jacksons Lane

Sheet Title:
Truss Grid 1:100 Extension


Scale: 1:100

Date: 01/07/2022

Drawn By: S Jackson

Load In Door
(level with street)

Downstairs - Dressing Room Corridor to Stage
Upstairs - Dressing Room Corridor to Balcony

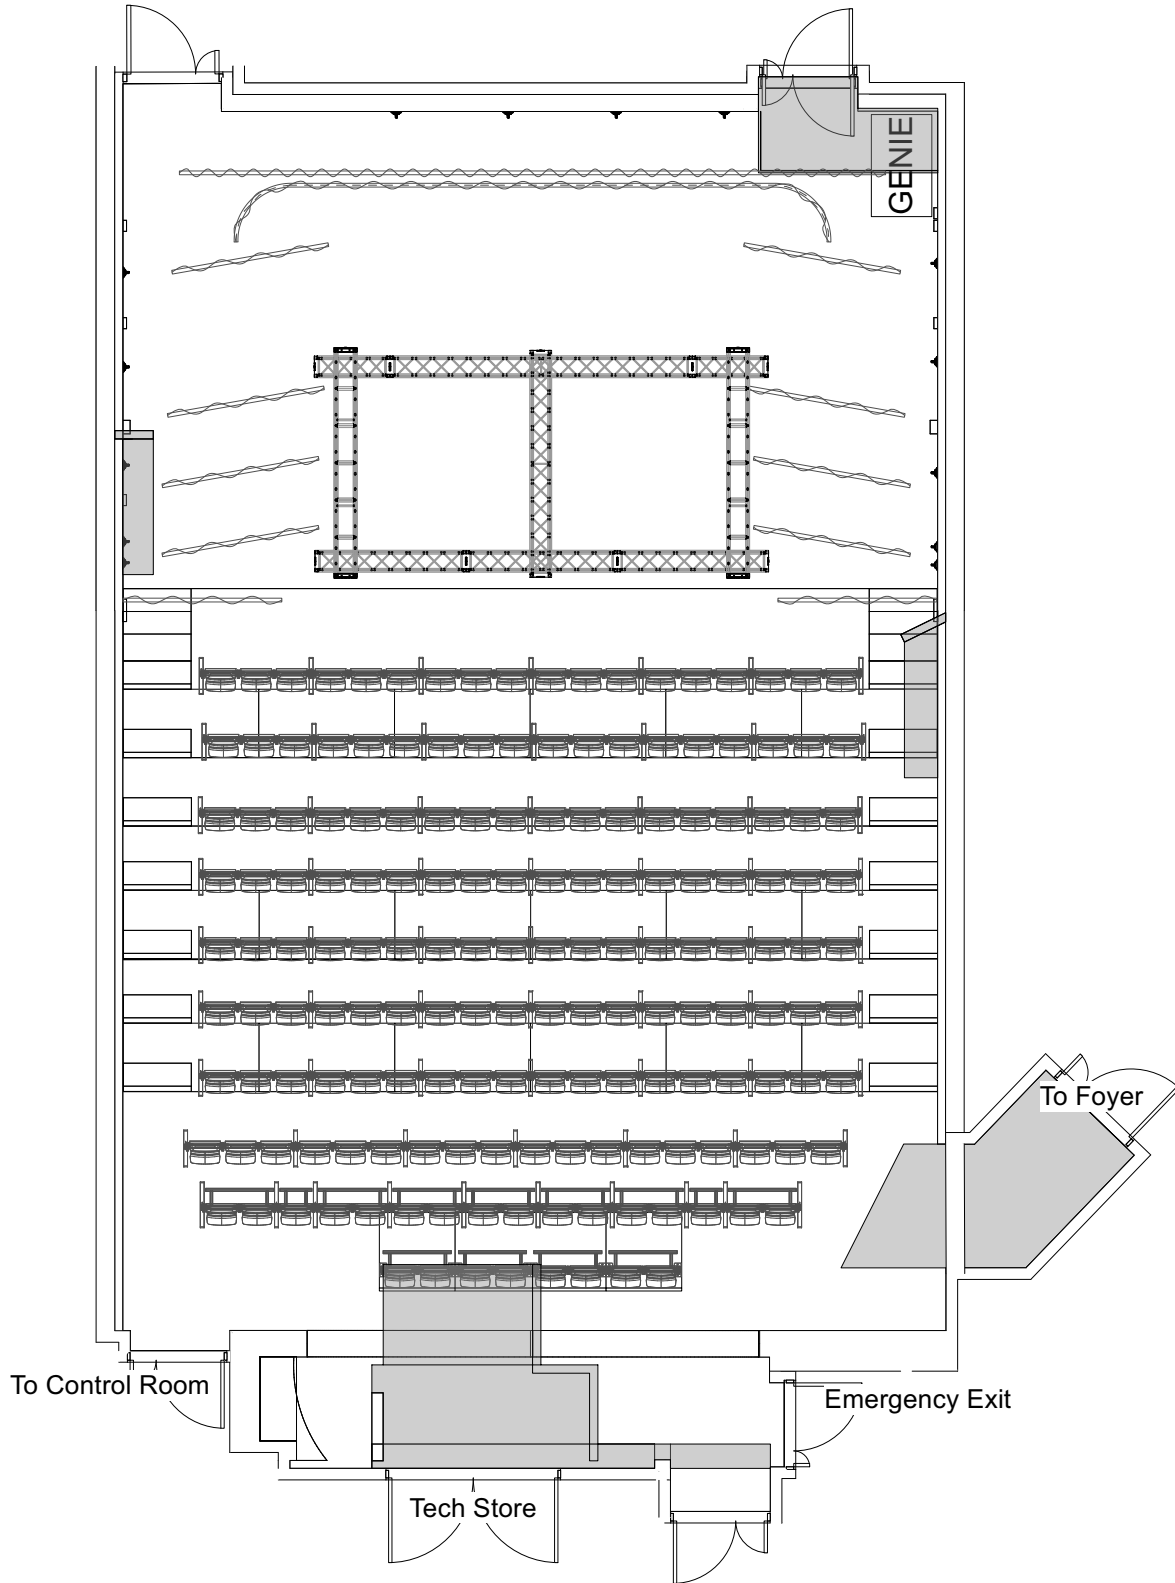

Jacksons Lane

Sheet Title:
Truss Grid 1:100 No Extension


Scale: 1:100

Date: 01/07/2022

Drawn By: S Jackson

Load In Door
(level with street)


Downstairs - Dressing Room Corridor to Stage
Upstairs - Dressing Room Corridor to Balcony

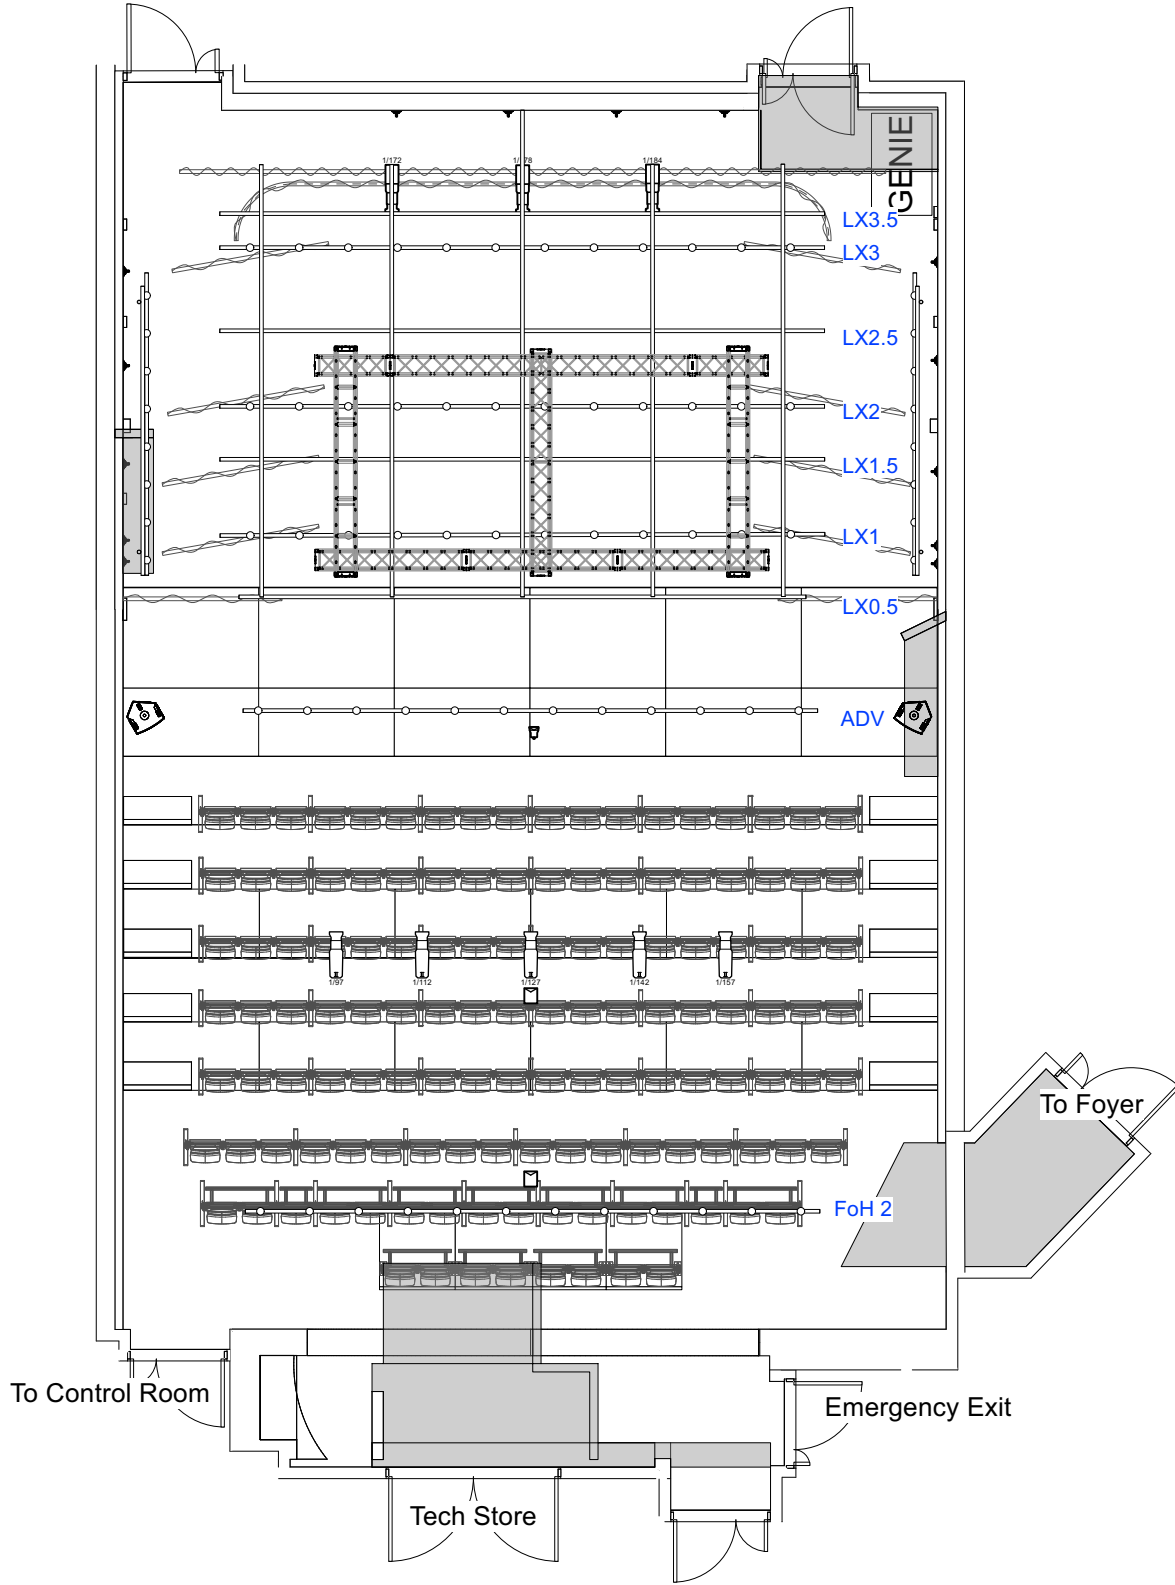

Jacksons Lane		
Sheet Title: Truss and Lighting 1:100 Extension		
Scale: 1:100		Date: 01/07/2022
Drawn By: S Jackson		

Load In Door
(level with street)

Downstairs - Dressing Room Corridor to Stage
Upstairs - Dressing Room Corridor to Balcony

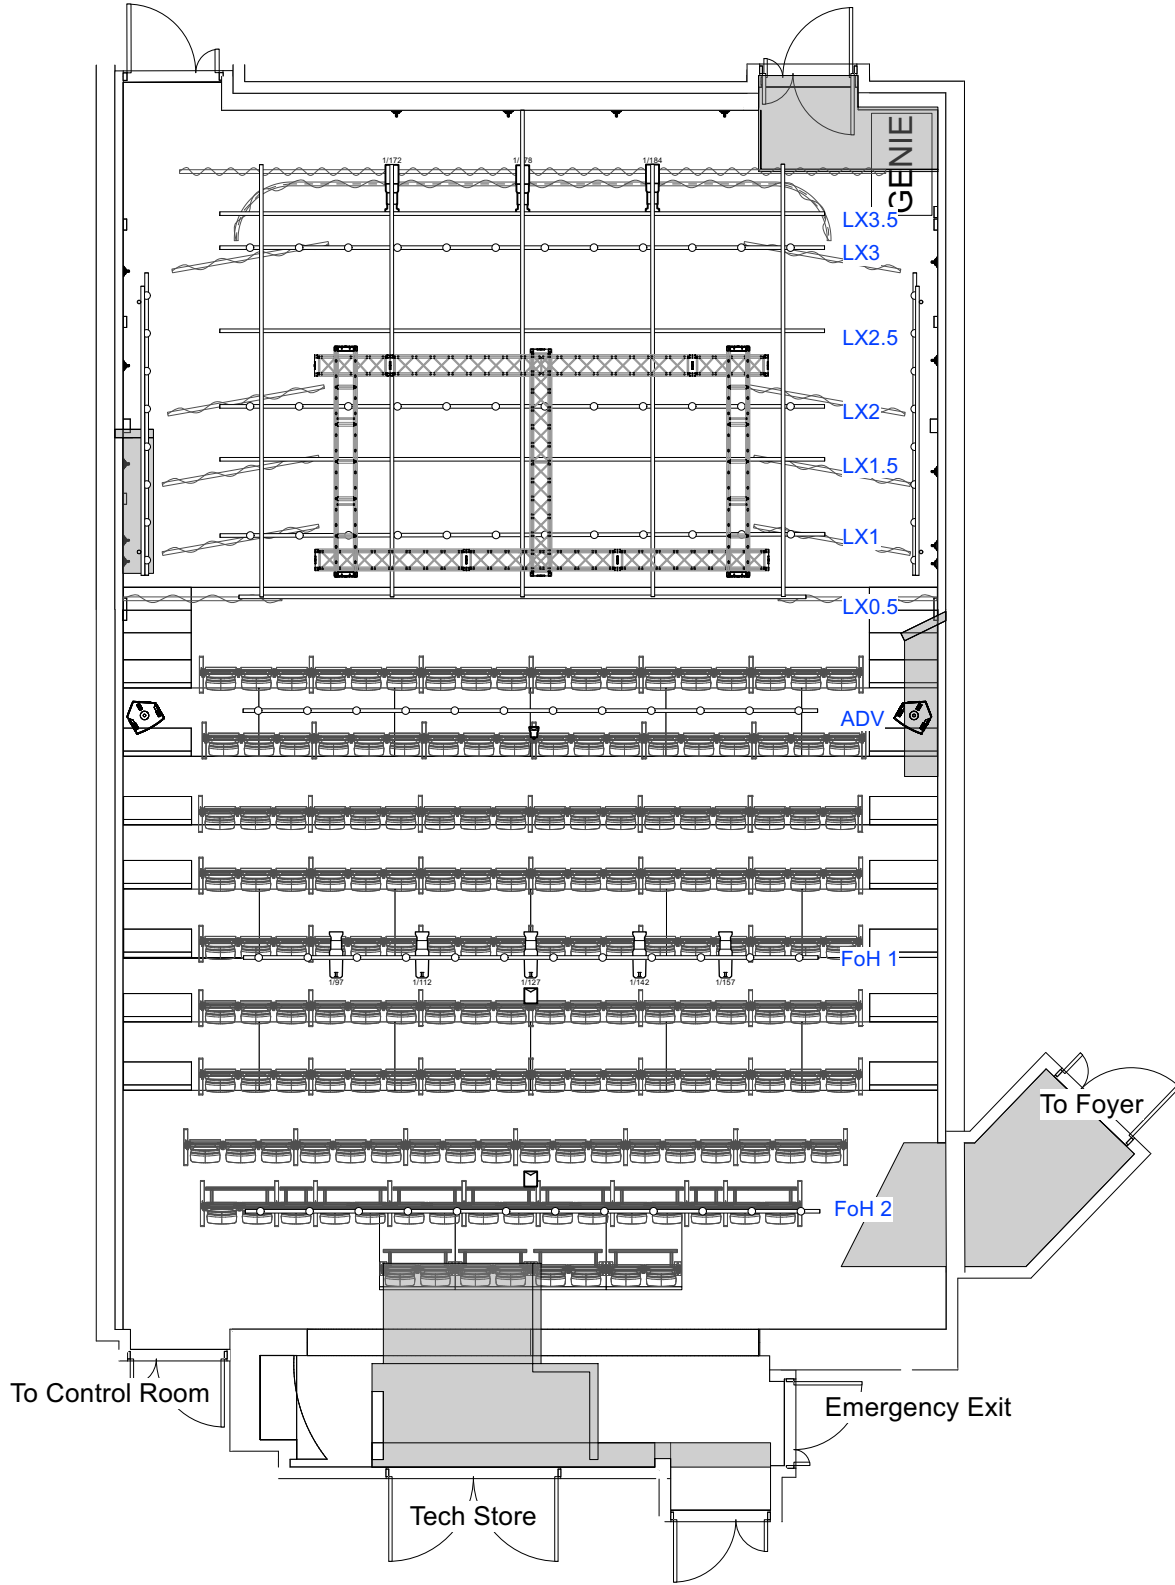

Jacksons Lane

Sheet Title :
Truss and Lighting 1:100 Full


Scale : 1:100

Date : 01/07/2022

Drawn By : S Jackson

Load In Door
(level with street)

Downstairs - Dressing Room Corridor to Stage
Upstairs - Dressing Room Corridor to Balcony

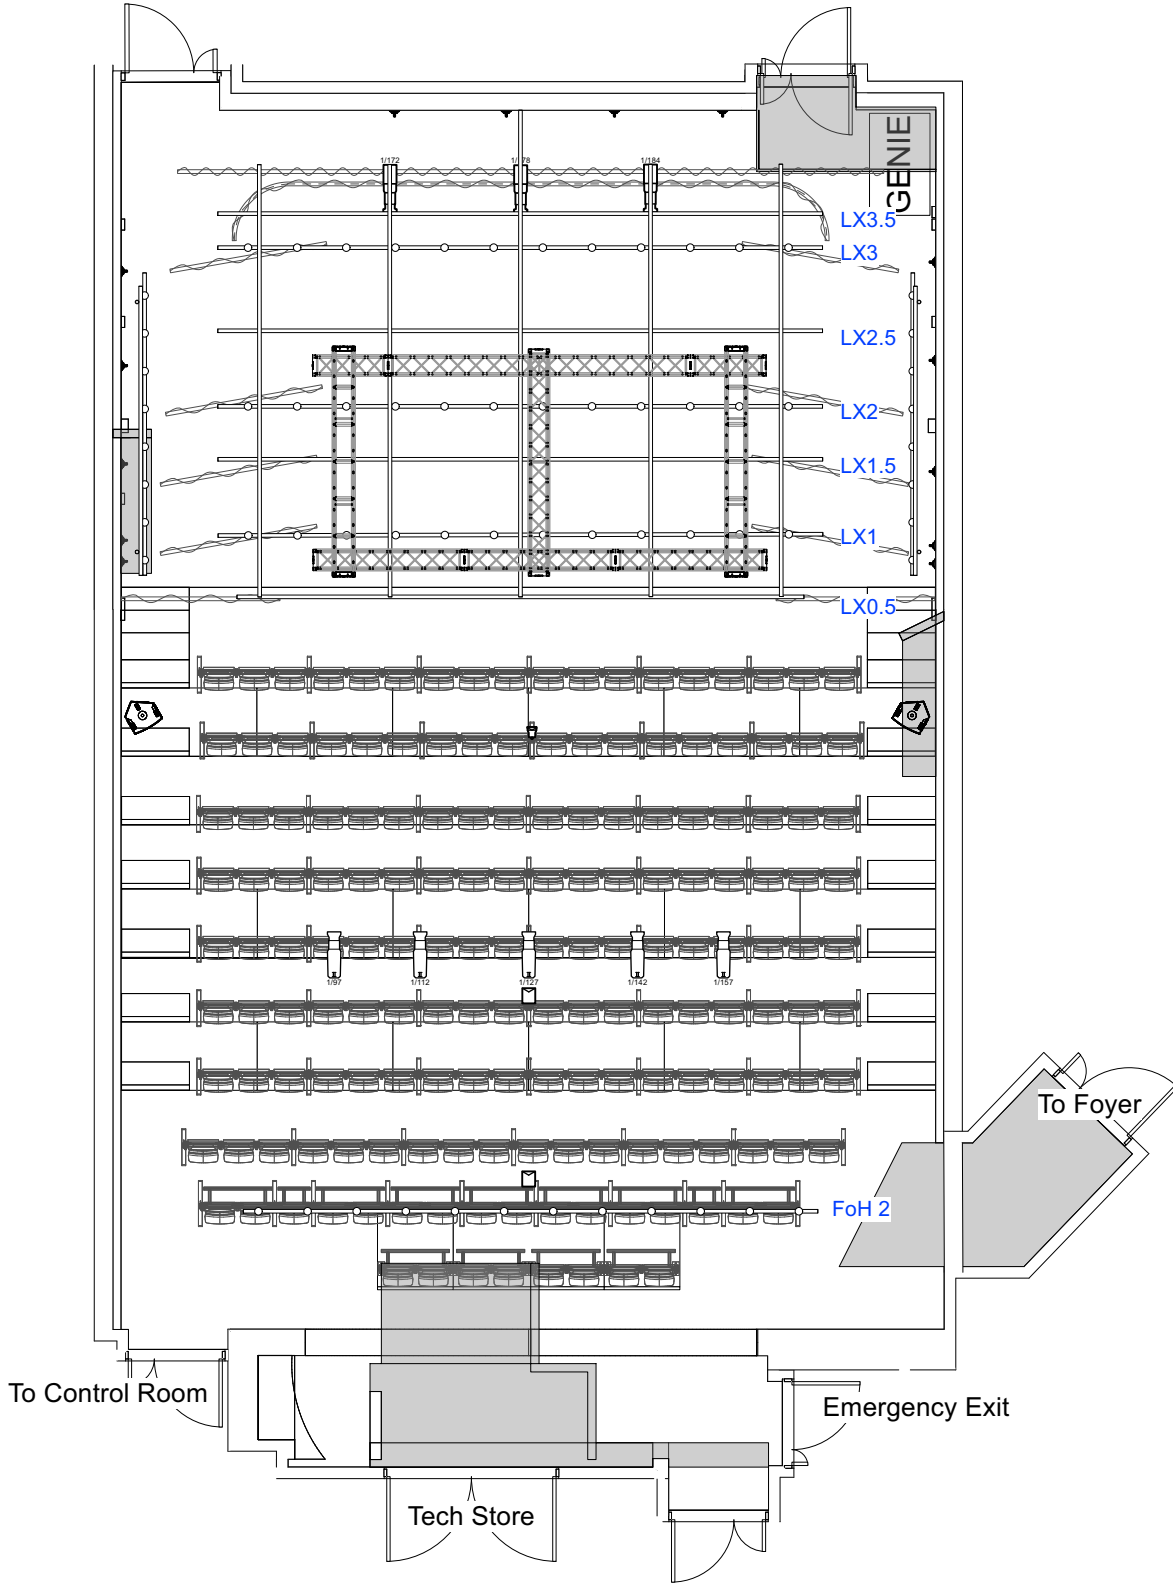

Jacksons Lane


Sheet Title :
Truss and Lighting 1:100 No Extension

Scale : 1:100


Date : 01/07/2022

Drawn By : S Jackson

Side Elevation Stage Right

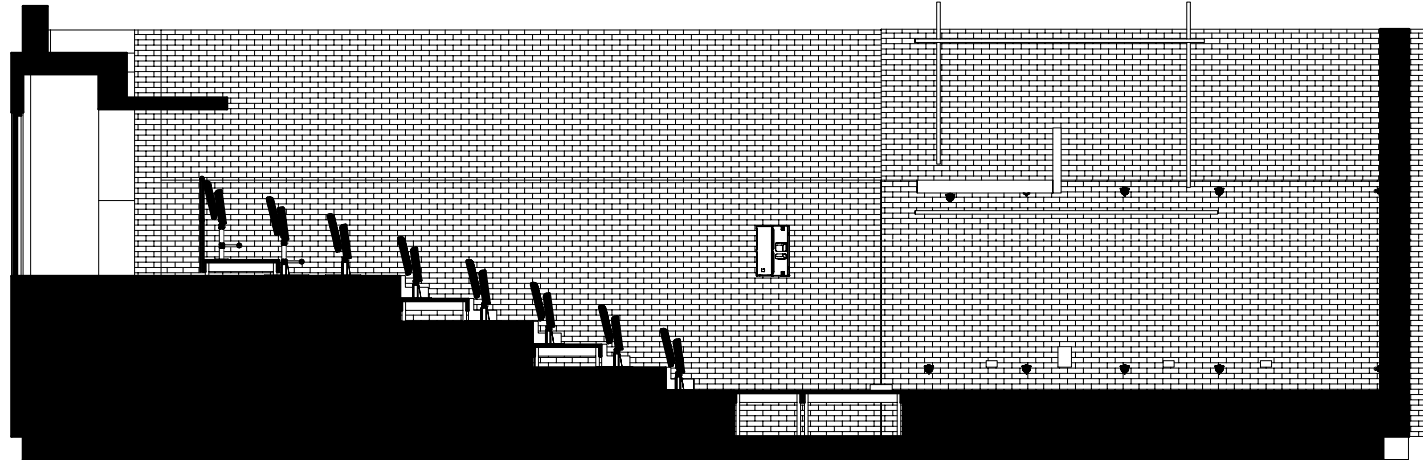

Side Elevation Stage Left

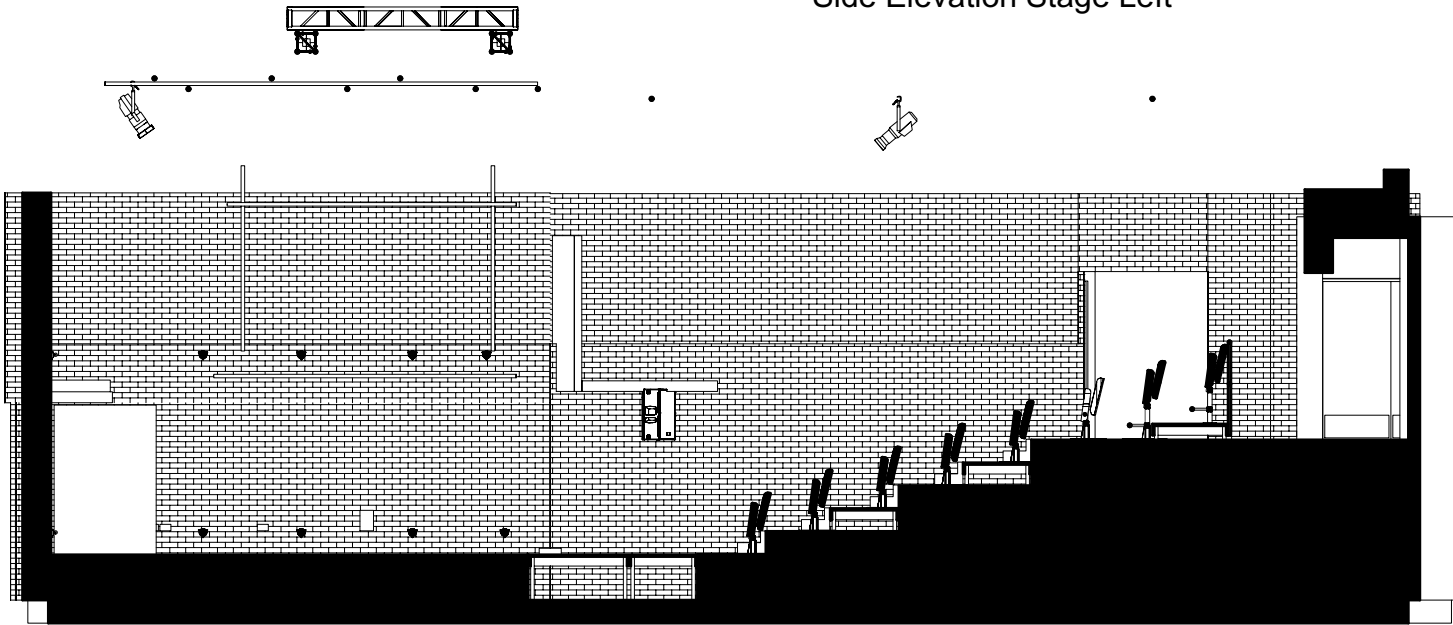

Jacksons Lane

269a Archway Road
London
N6 5AA


Sheet Title:
Lighting Side Elevation Extension

Scale: 1:100


Date: 01/07/2022

Drawn By: S Jackson

Side Elevation Stage Right

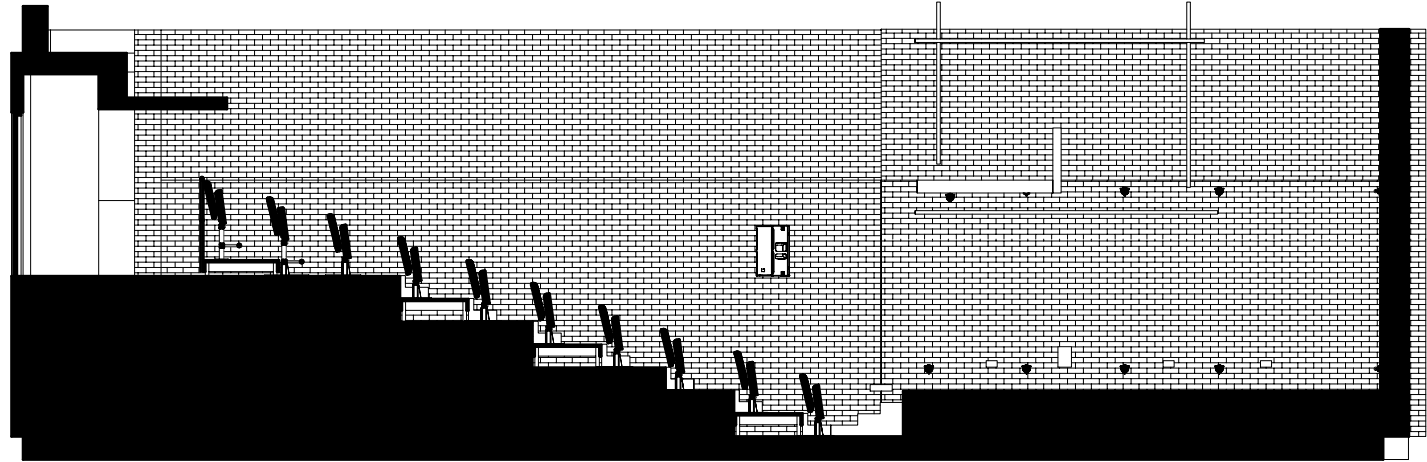

Side Elevation Stage Left

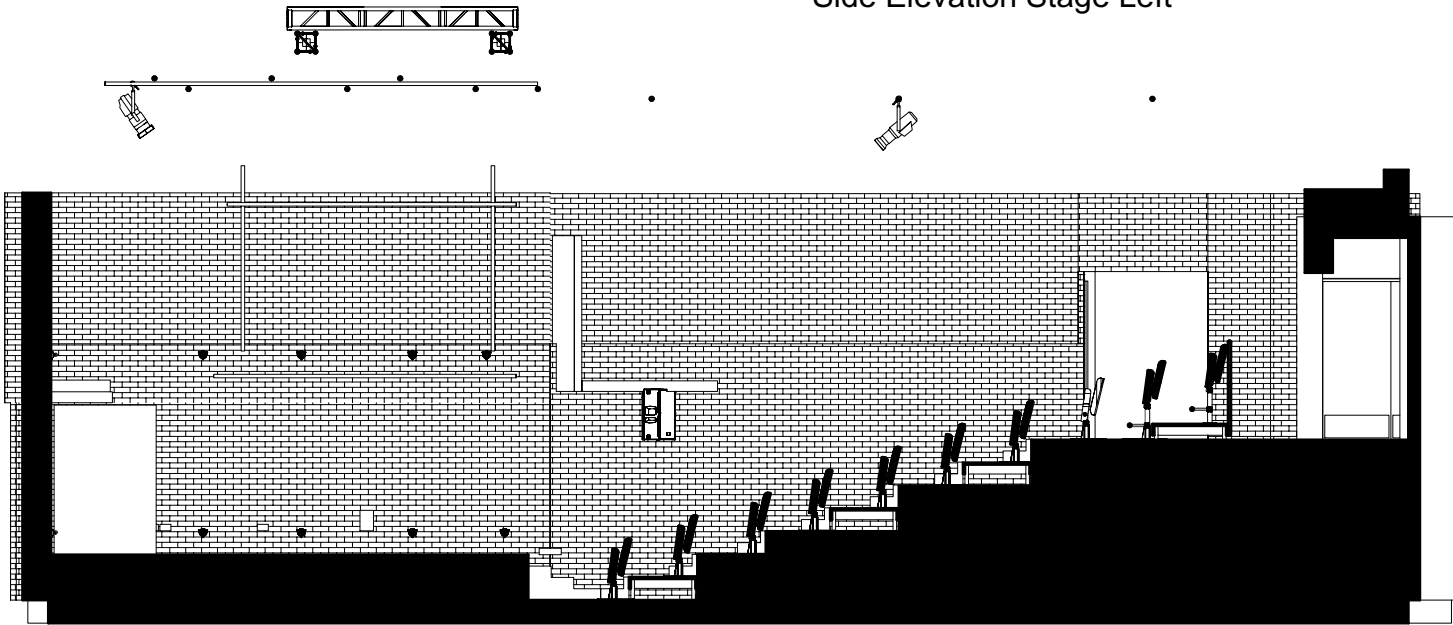

Jacksons Lane

269a Archway Road
London
N6 5AA


Sheet Title:
Lighting Side Elevation Full

Scale: 1:100


Date: 01/07/2022

Drawn By: S Jackson

Side Elevation Stage Right

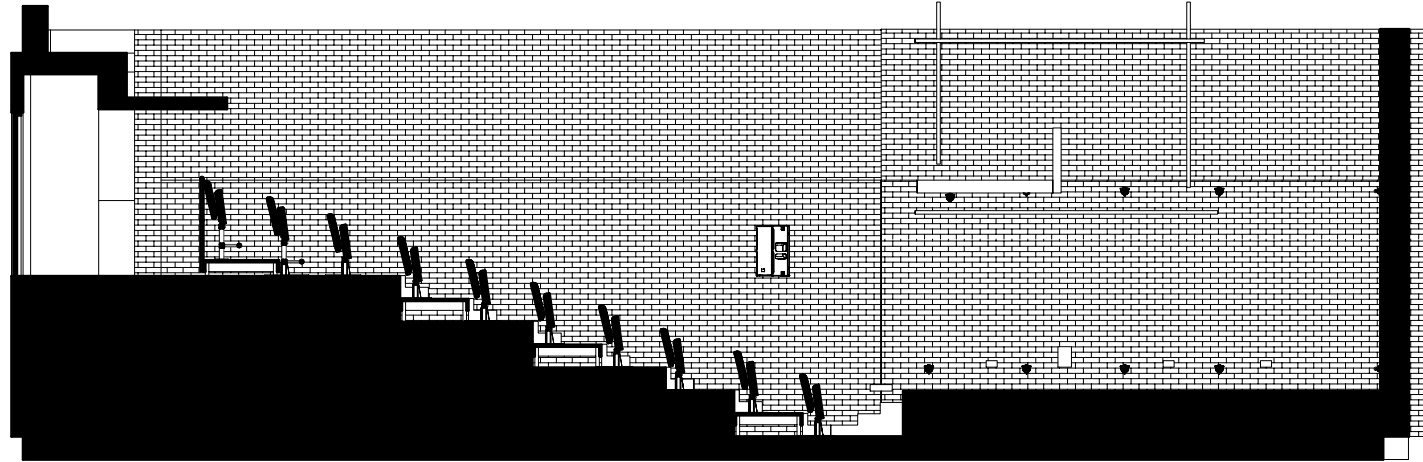

Side Elevation Stage Left

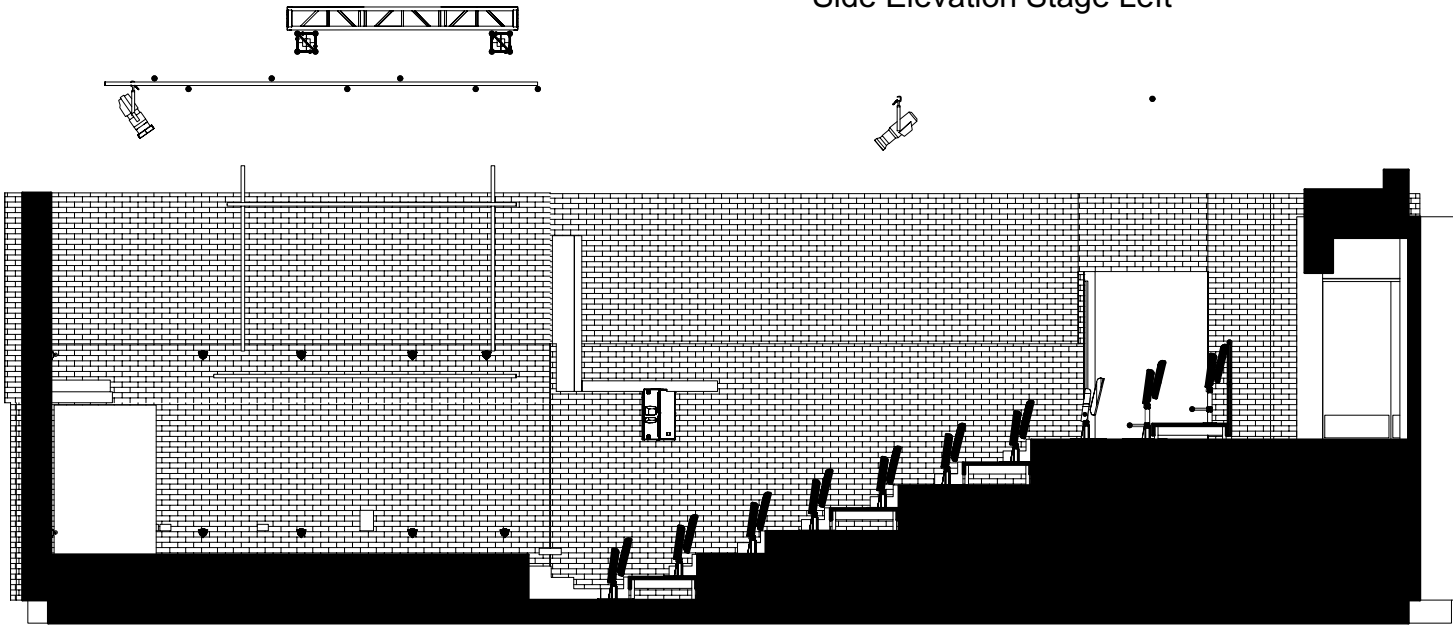

Jacksons Lane

269a Archway Road
London
N6 5AA

Sheet Title:
Lighting Side Elevation No Extension

Scale: 1:100

Date: 01/07/2022

Drawn By: S Jackson